


MAIN LEVEL FLOOR PLAN

SCALE: 1/4" = 1'-0"

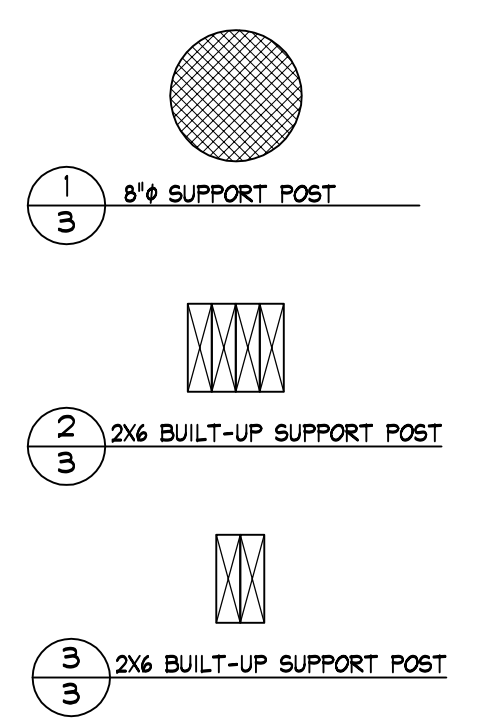

DATE	REV #	DESCRIPTION
3/9/15	1	UPDATED PER SALES ORDER DATED 3/9/15

Copyright Protected Design
Beaver Mountain Log
& Cedar Homes 2015

Ⓢ ELECTRIC SMOKE DETECTOR WIRED TO LIGHTING CIRCUIT. ACTIVATION OF ONE ALARM SOUNDS ALL DETECTORS. POWER BACKUP REQUIRED.

Ⓢ CARBON MONOXIDE DETECTOR TO BE INSTALLED NEAR BEDROOM AT EACH LEVEL CONTAINING BEDROOM. ADDITIONAL DETECTOR TO BE INSTALLED INSIDE BEDROOM WITH FUEL-FIRED APPLIANCE OR FIREPLACE. PERMANENT INSTALLATION TO BE WIRED TO LIGHTING CIRCUIT WITH NO DISCONNECT.

BUILDER NOTE: REFER TO THE ASSEMBLY DETAIL HANDBOOK FOR ADDITIONAL INSTALLATION INFORMATION & SPECIFIC CONSTRUCTION DETAILS	
STRUCTURAL DESIGN CRITERIA ROOMS OTHER THAN SLEEPING ROOMS 40 psf (LIVE)/10 psf (DEAD) SLEEPING ROOMS 30 psf (LIVE)/10 psf (DEAD) GROUND SNOW 40 psf GEOGRAPHIC DESIGN CRITERIA BASIC WIND SPEED - 90 mph SEISMIC DESIGN CAT. C WEATHERING - SEVERE FROST LINE DEPTH - 48" TERMITES - MOD. TO HEAVY FLOOD HAZARD - ____ WINTER DESIGN TEMP. 10° F AIR FREEZING TEMP. ____ ICE SHIELD UNDERLAYMENT REQ'D DECAY - SLIGHT TO MOD.	
DRAWN BY: JCP DATE: 2/18/15	TITLE: ROARING BROOK LOG HOMES CUSTOM HOME HOMESTYLE: 30' X 42' CAPE W/ 26' X 24' CAPE GARAGE PROJECT #: _____ REVISION: 1 DWG. #: 3 OF 11



1740 County Hwy 48
Deposit, NY 13754
Phone: (800) 233-2770
www.beavermtn.com